

IIBEC International Convention & Trade Show

March 9-10, 2024

Phoenix Convention Center - Exhibition Hall 5&6

North Building - Lower Level


Phoenix, AZ



Show Information	
Show	IIBEC International Convention & Trade Show
Show Dates	March 9-10, 2024
Move-In	03/07/24
Job #	L180630324
AE	Randy Hilker

Inventory as of 02/22/2023

Dimension	Size	Qty	SqFt
10'x10'	100	96	9,600
10'x20'	200	39	7,800
20'x20'	400	18	7,200
20'x30'	600	4	2,400
20'x40'	800	1	800
20'x50'	1,000	2	2,000
40'x65'	2,600	1	2,600
Totals:	161	32,400	

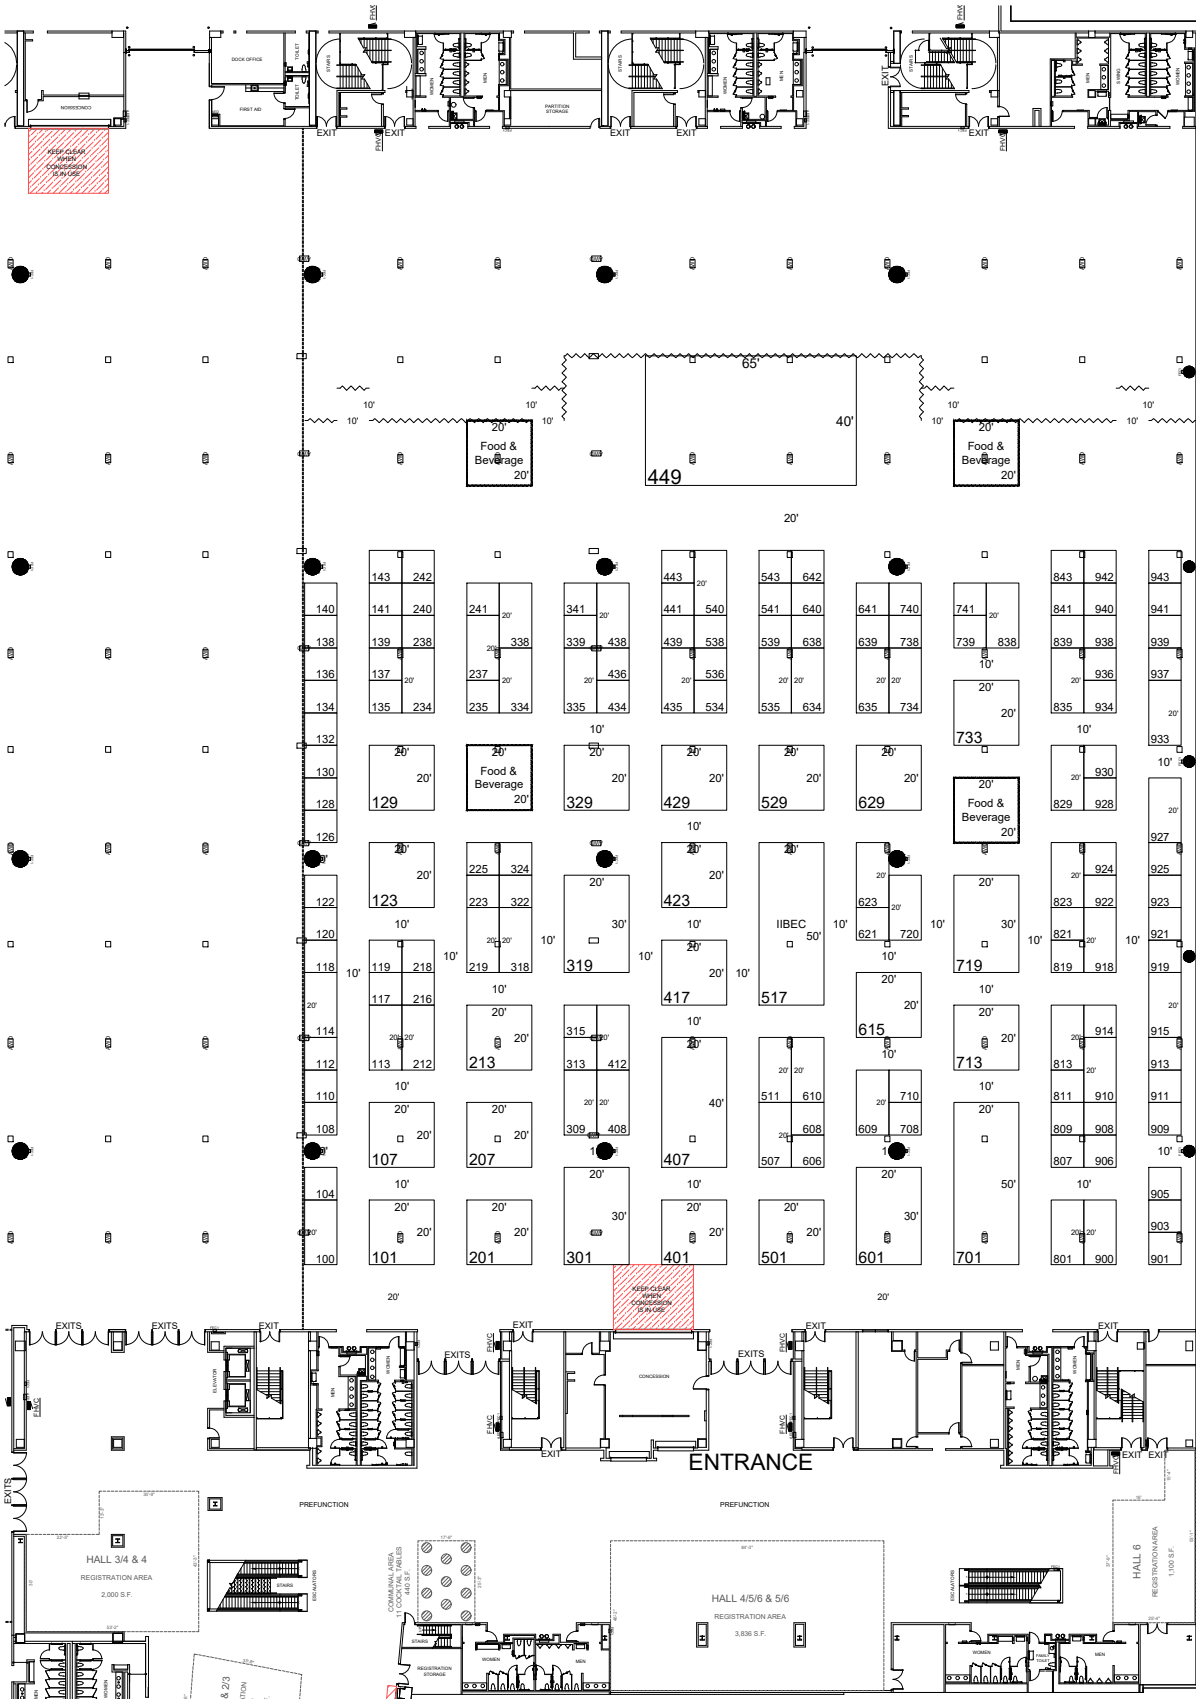

Floor Plan Legend	
FE	Fire Extinguisher
FS	Fire Strobe
FHC	Fire Hose Cabinet

Venue Info	
Building Name	Phoenix Convention Center
Hall	Exhibition Hall 5&6
Floor	North Building - Lower Level
Address	100 N 3rd St Phoenix, AZ 85004

Drawing Information	
File Path	J:\01_Floor Plans_01_BES SHOW FLOORPLANS\2024\03_March\IIBEC Int Conv_L180630324
File Name	IIBEC Int Conv_L180630324.dwg
Drawn By	Nicholas Pedersen
Last Saved	2/21/2023 12:38 PM
Saved By	Npedersen
Tab	Floorplan
Paper Size	ANSI full bleed A (11.00 x 8.50 inches)
Scale	NTS

Shepard Exposition Services has made every effort to ensure the accuracy of all information contained on this floor plan. However, no warranties, either expressed or implied, are made with respect to this floor plan. Verifying the locations of building columns, utilities, or other architectural components of the facility is the sole responsibility of the exhibitor/show management.

SUBJECT TO FIRE MARSHAL APPROVAL

1531 Carroll Drive NW
Atlanta, GA 30318
(v) 404-720-8600
(f) 404-720-8700